




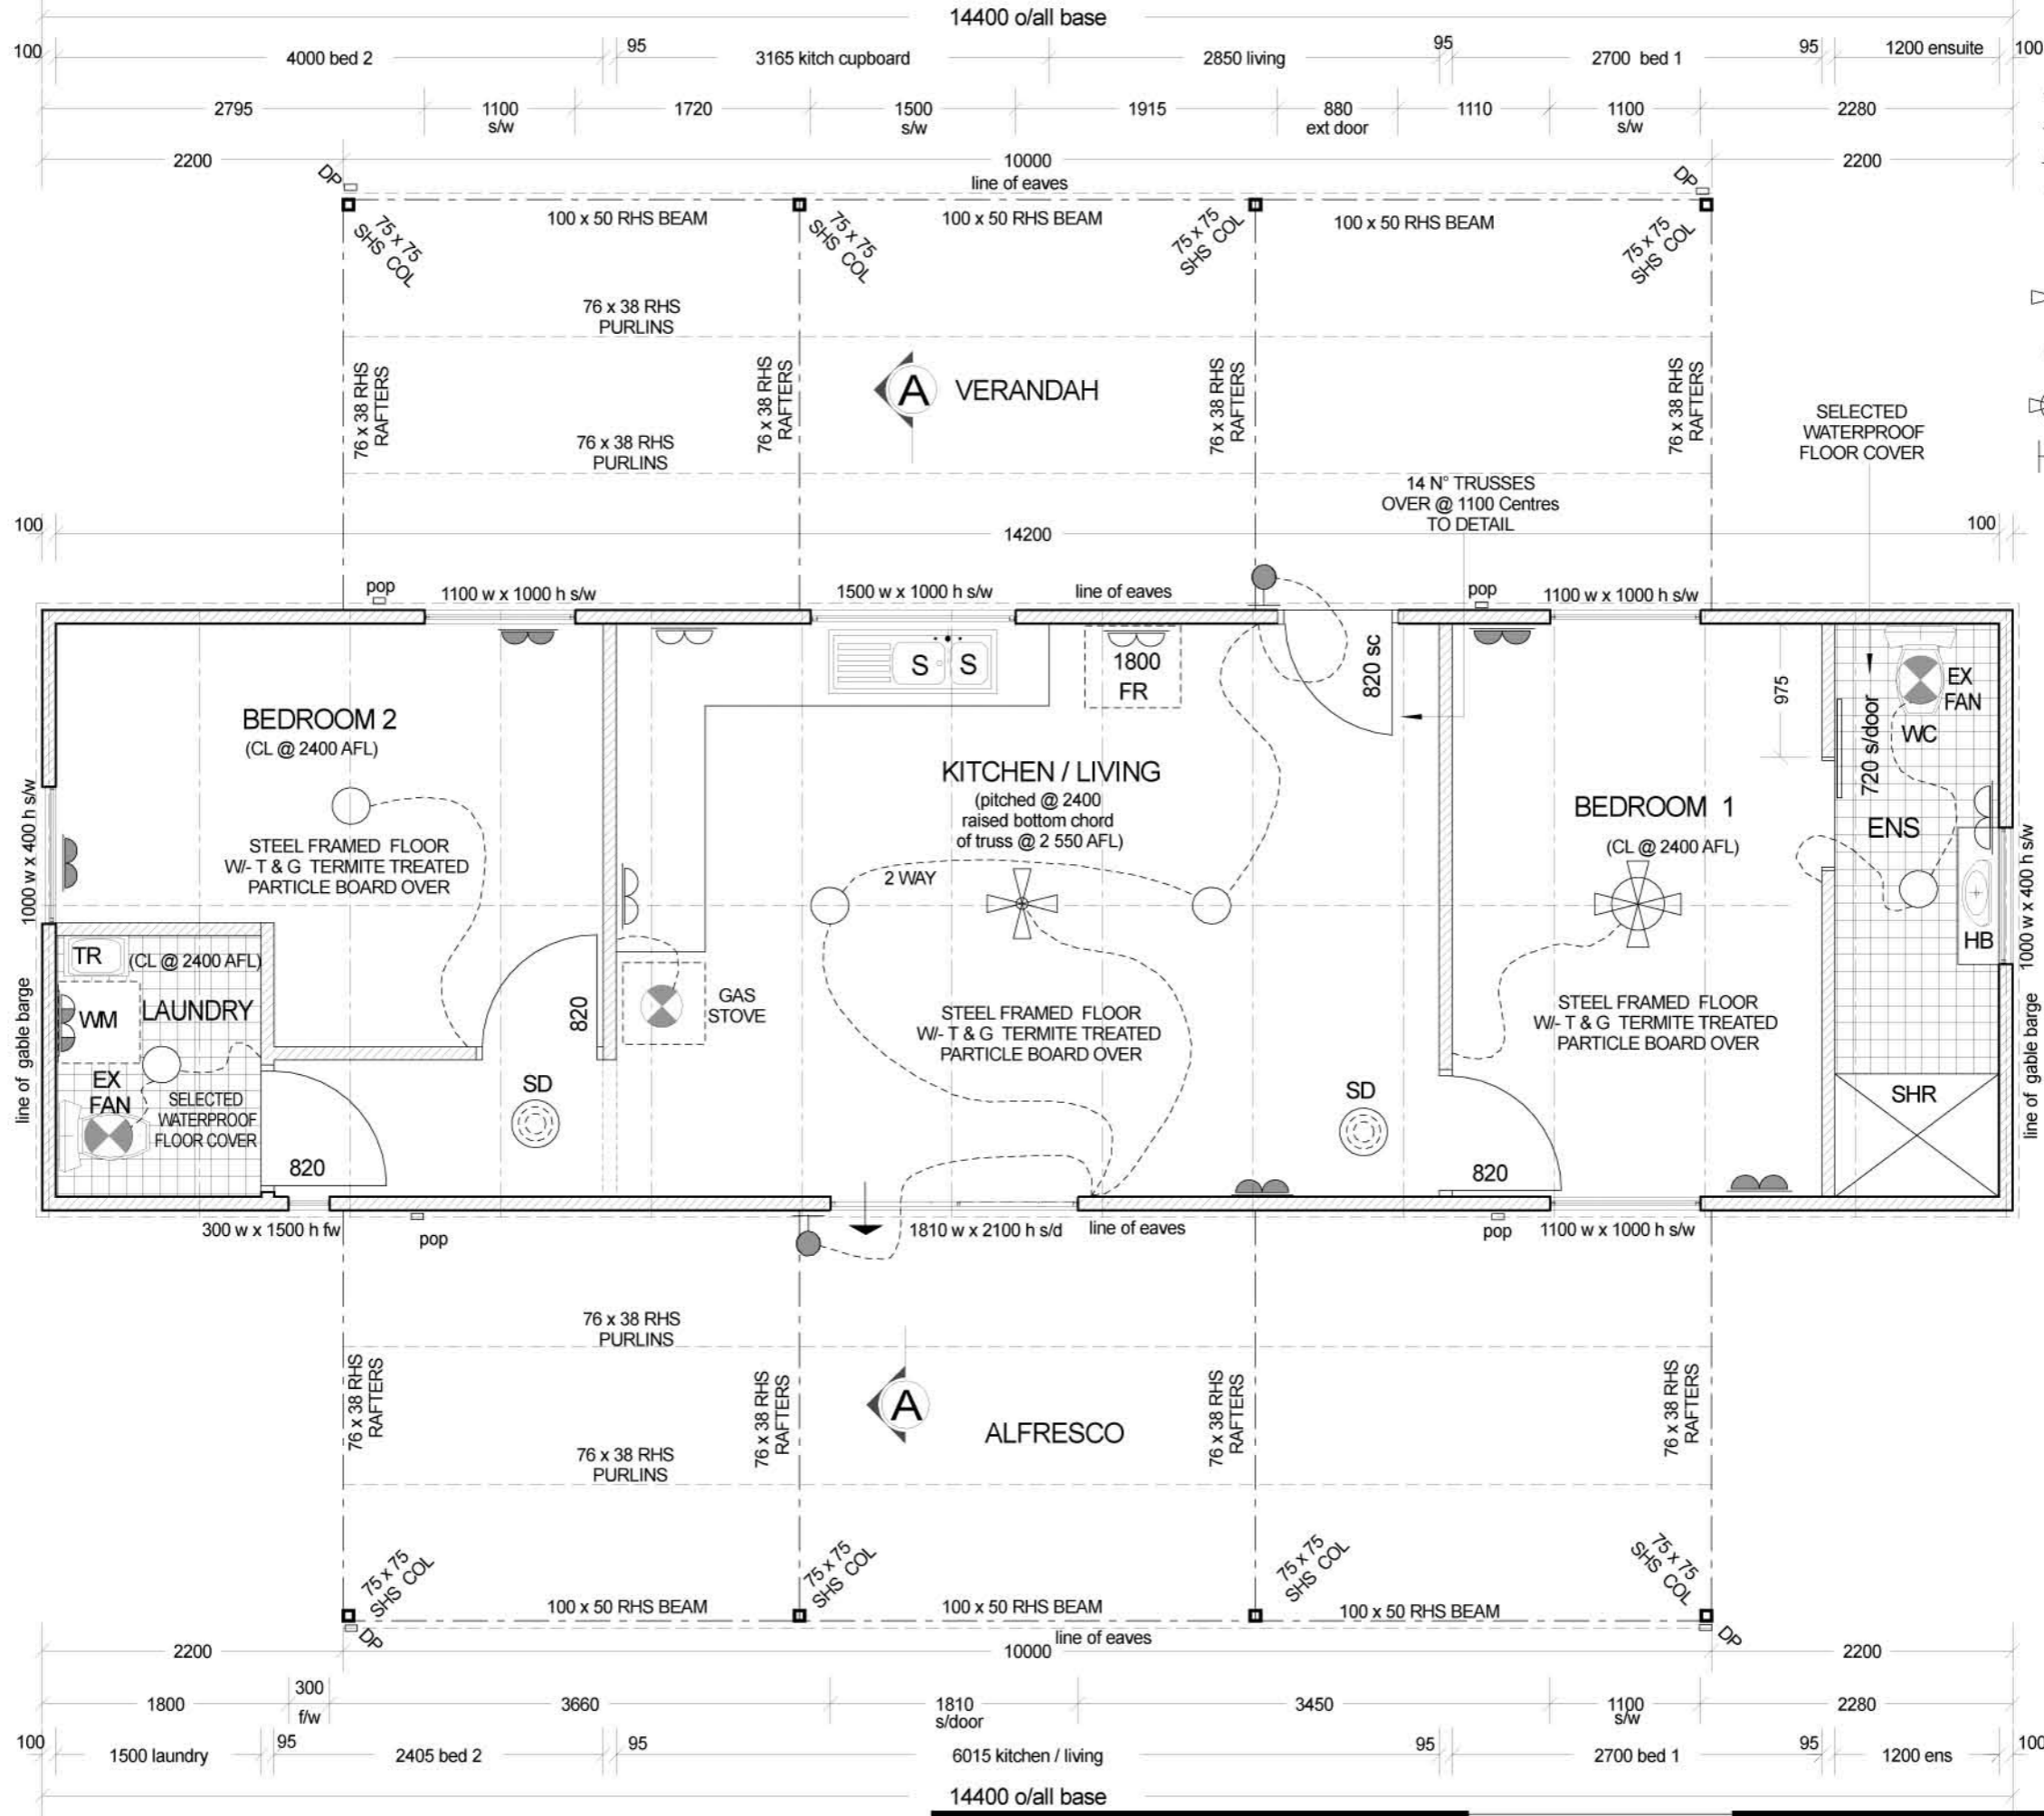
3 1

ELECTRICAL LEGEND

-  DOUBLE GPO @ 300 AFL
-  DOUBLE GPO @ 1000 AFL
-  DOUBLE GPO @ 1350 AFL
-  EXHAUST FAN
-  SMOKE DETECTOR
-  CEILING FAN
-  CEILING LIGHT
-  CEILING FAN W- LIGHT
-  WALL LIGHT 2000 AFL

FLOOR PLAN

scale 1:50



NOTE : Internal studs are 75mm 1.12mm high tensile steel.
External studs are 90mm 1.12mm high tensile steel.

Date Aug 2015
Drawn M.A
Scale AS SHOWN

COPYRIGHT © RESERVED

Sheet N°
1A OF 4
ISSUE

4 2