
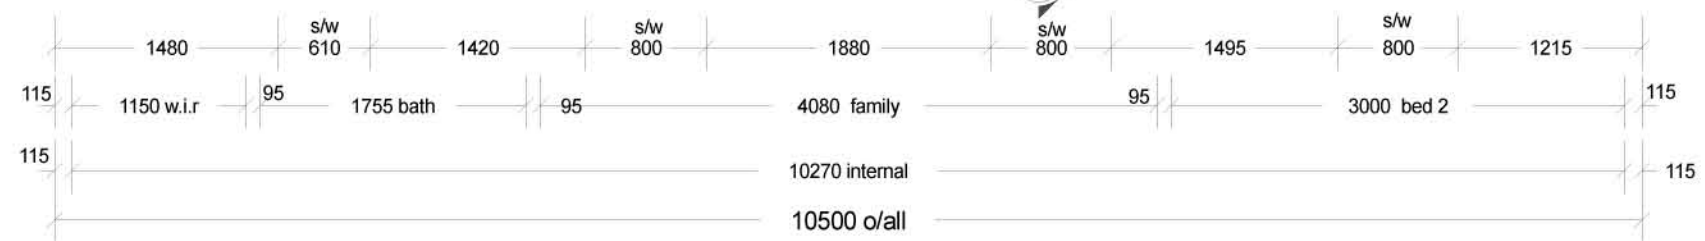
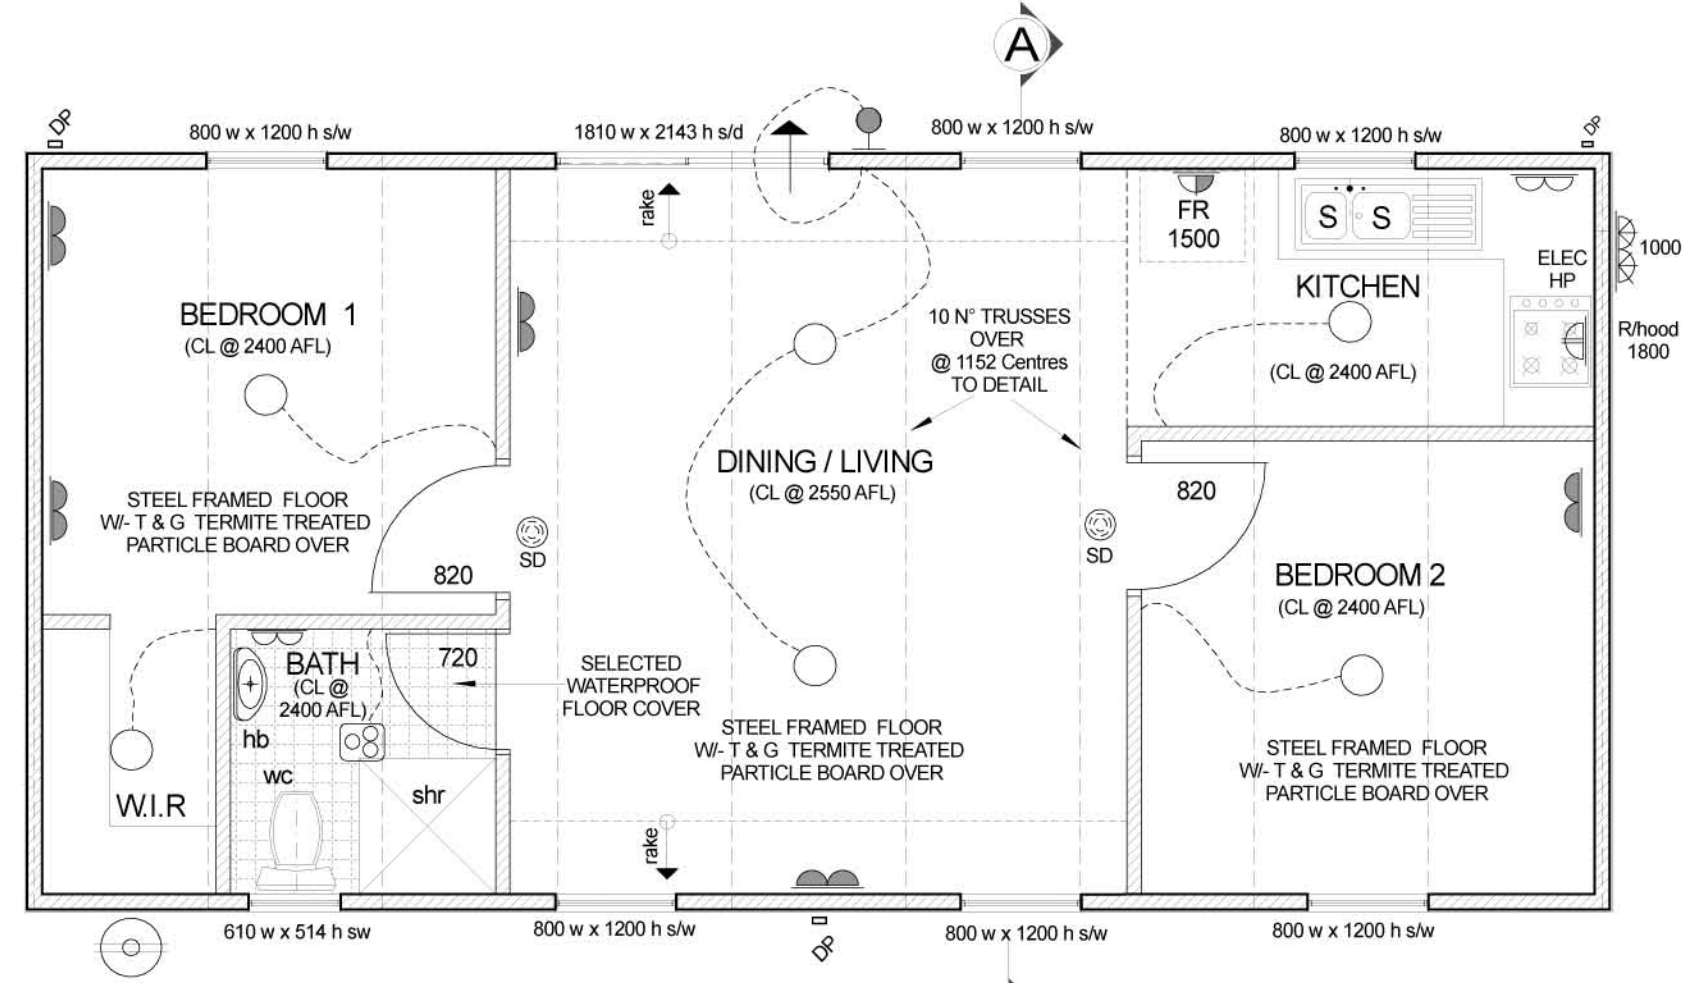


ELECTRICAL LEGEND

- CEILING LIGHT
- ⊙ WALL LIGHT 2000 AFL
- ⌒ DOUBLE GPO @ 300 AFL
- ⌒ DOUBLE GPO @ 975 AFL
- ⌒ GPO FOR APPLIANCE @ 1800AFL
- ⌒ DOUBLE GPO @ 1350 AFL
- ⌒ SINGLE GPO @ 1500 AFL
- ⌒ W/PROOF DGPO @ 1000 AFL
- ⊗ EXHAUST FAN
- ⊙ SMOKE DETECTOR
- ⊙ 50 litre electric storage hww
- ⊙ IXL TASTIC (fan light heater)

4 1

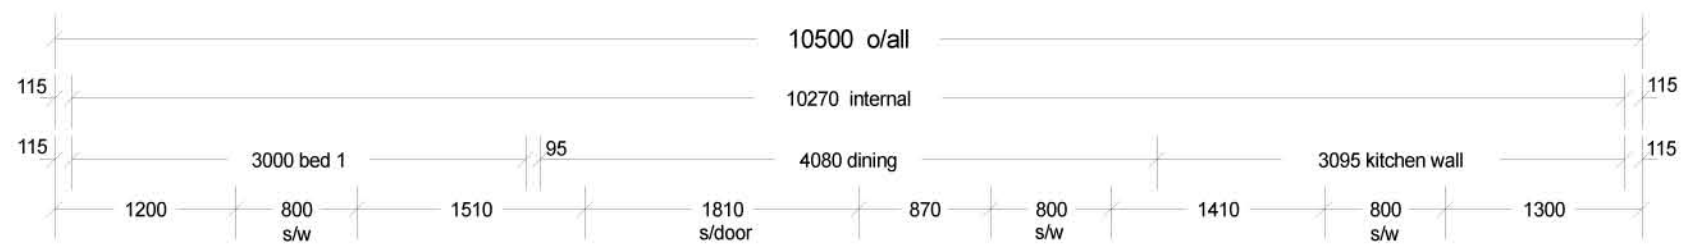

2 3

FLOOR PLAN
scale 1:50

NOTE : Internal studs are 75mm 1.12mm high tensile steel.
External studs are 90mm 1.12mm high tensile steel.

Date April 2017
Drawn M.A
Scale AS SHOWN

COPYRIGHT © RESERVED

Sheet N°
2A OF 4
ISSUE