


4 2

ELECTRICAL LEGEND

- CEILING LIGHT
- WALL LIGHT 2000 AFL
- ⌒ DOUBLE GPO @ 300 AFL
- ⌒ DOUBLE GPO @ 975 AFL
- ⌒ GPO FOR APPLIANCE @ 1800AFL
- ⌒ DOUBLE GPO @ 1350 AFL
- ⌒ SINGLE GPO @ 1500 AFL
- ⌒ W/PROOF DGPO @ 1000 AFL
- ⊗ EXHAUST FAN
- ⊙ SMOKE DETECTOR
- ⊙ 50 litre electric storage hwu
- ⊙ IXL TASTIC (fan light heater)

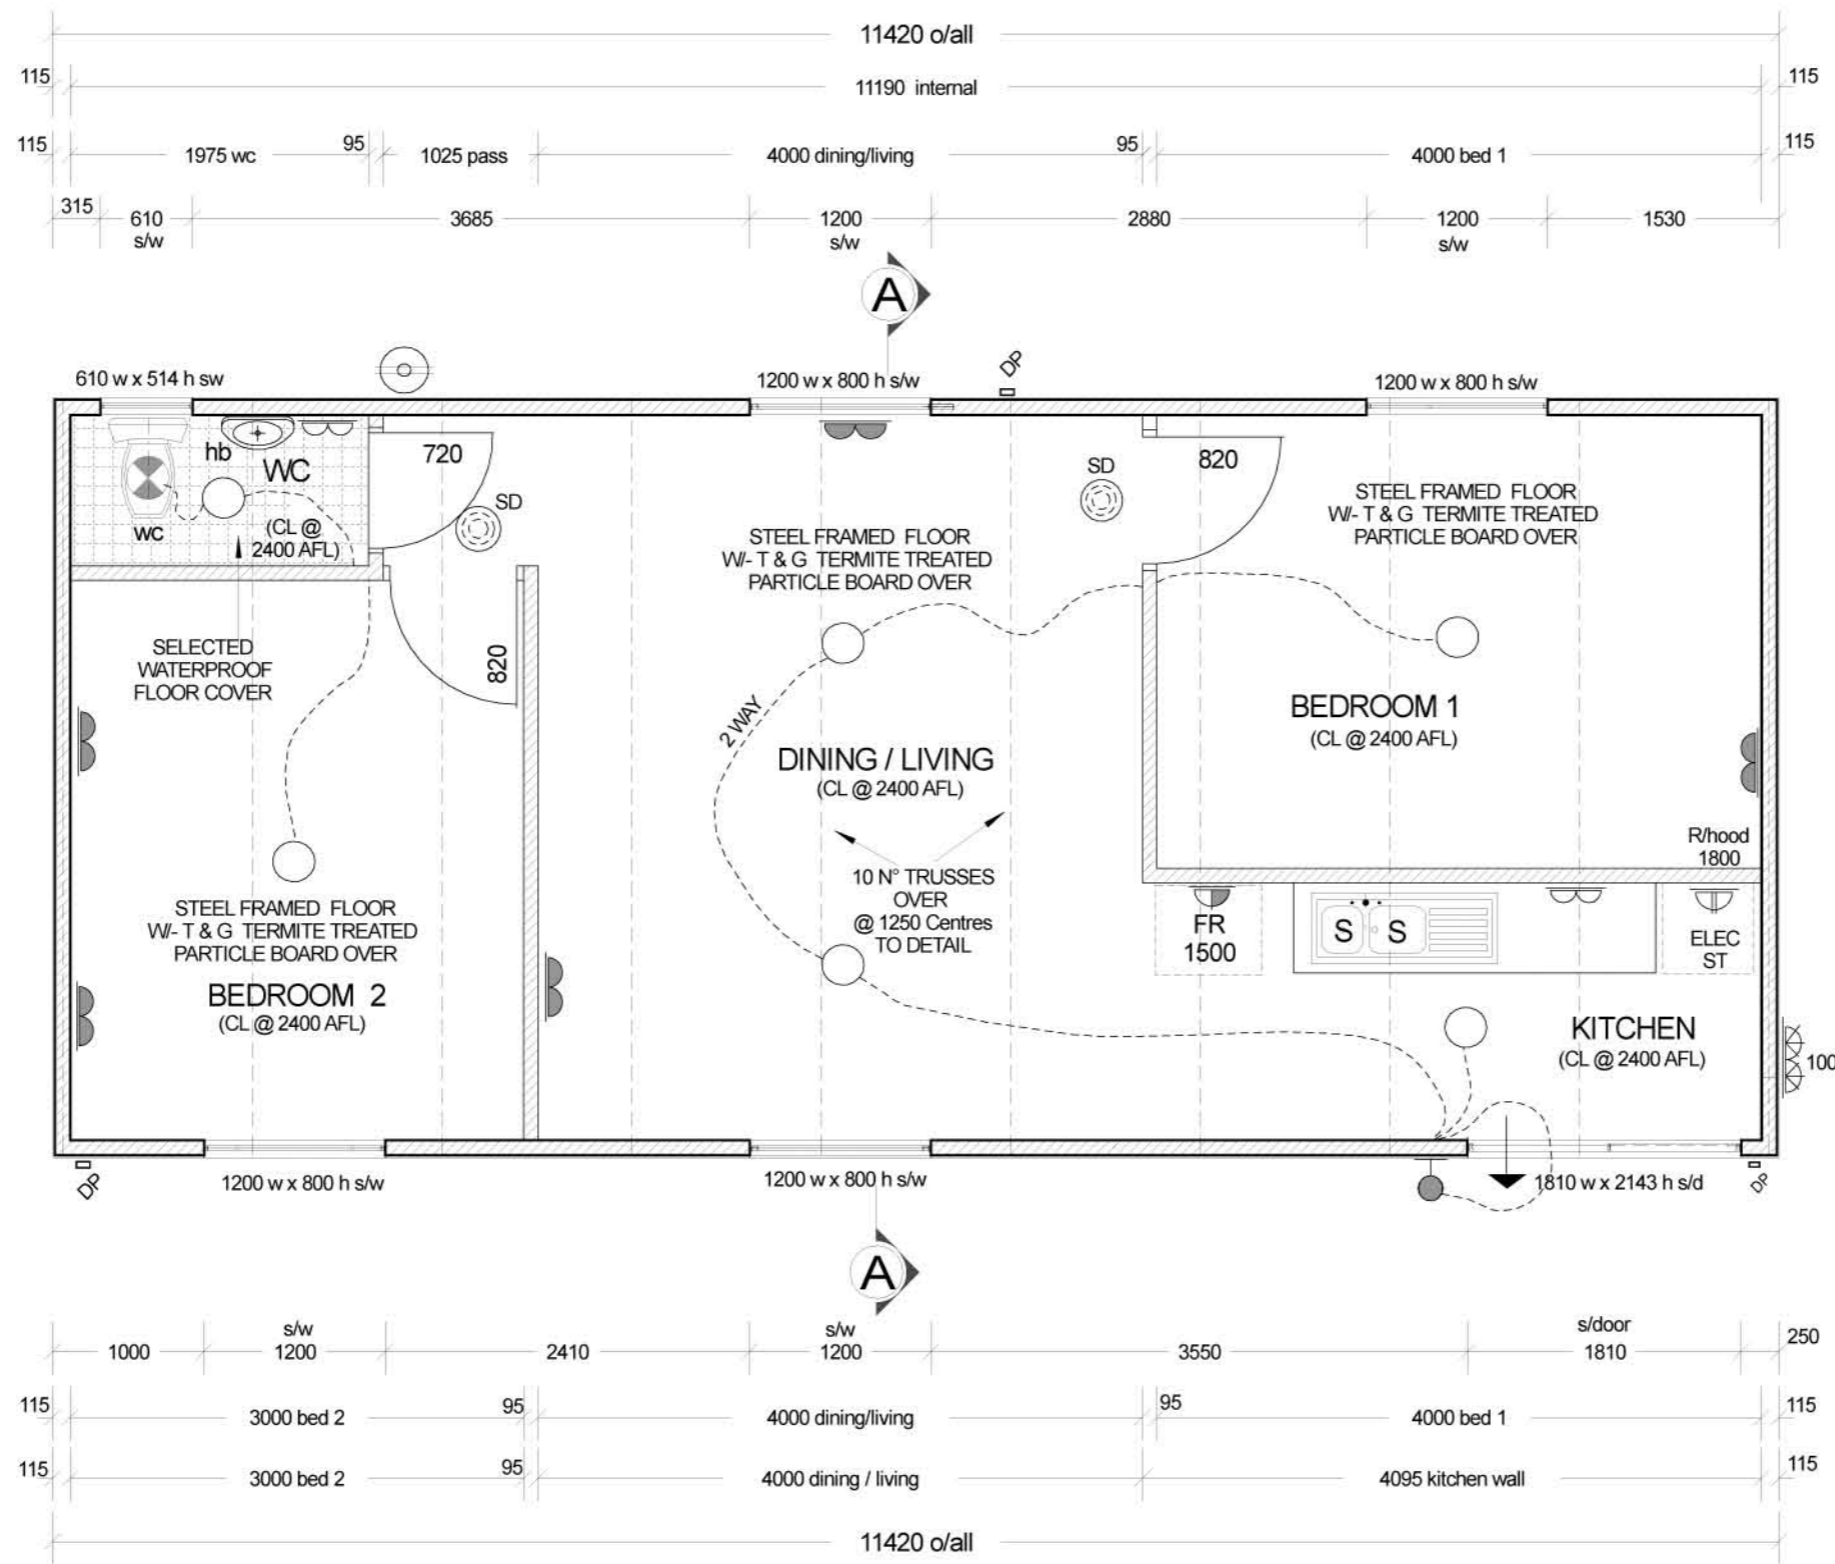

FLOOR PLAN
scale 1:50

1 3

NOTE : Internal studs are 75mm 1.12mm high tensile steel.
External studs are 90mm 1.12mm high tensile steel.

ALL DRAWINGS TO BE READ IN CONJUNCTION WITH BASIC DESIGN NOTES		SCALE : AS SHOWN								
KWA BUILDING		REVISION	CLIENT					DRN	Date Feb 2018	Sheet N° 2A OF 4 ISSUE
INSPECTION & CONSULTING CHARTERED PROFESSIONAL ENGINEER								APPROVED	Drawn M.A	
Lloyd's Worldwide Insurance for Geotechnical & Structural Engineering 1 TURRIFF RD FLOREAT Western Australia 6014 T +61 0414 341 543 / 08 9387 5431 F 08 9387 5432 E : mandarinwa@bigpond.com								DATE	Scale AS SHOWN	
				Sheet number	COPYRIGHT © RESERVED					