
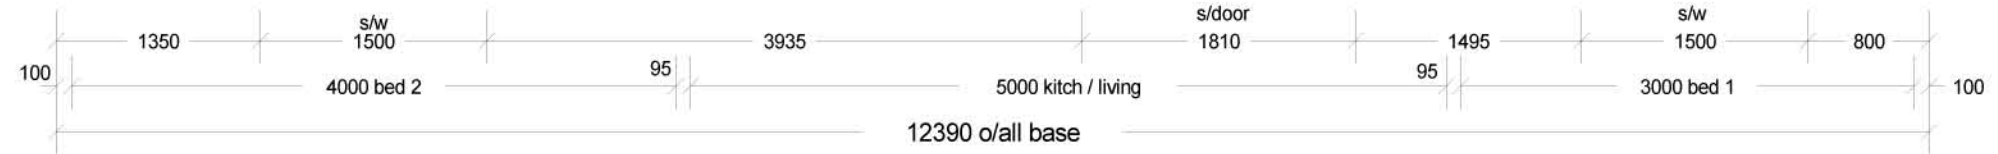
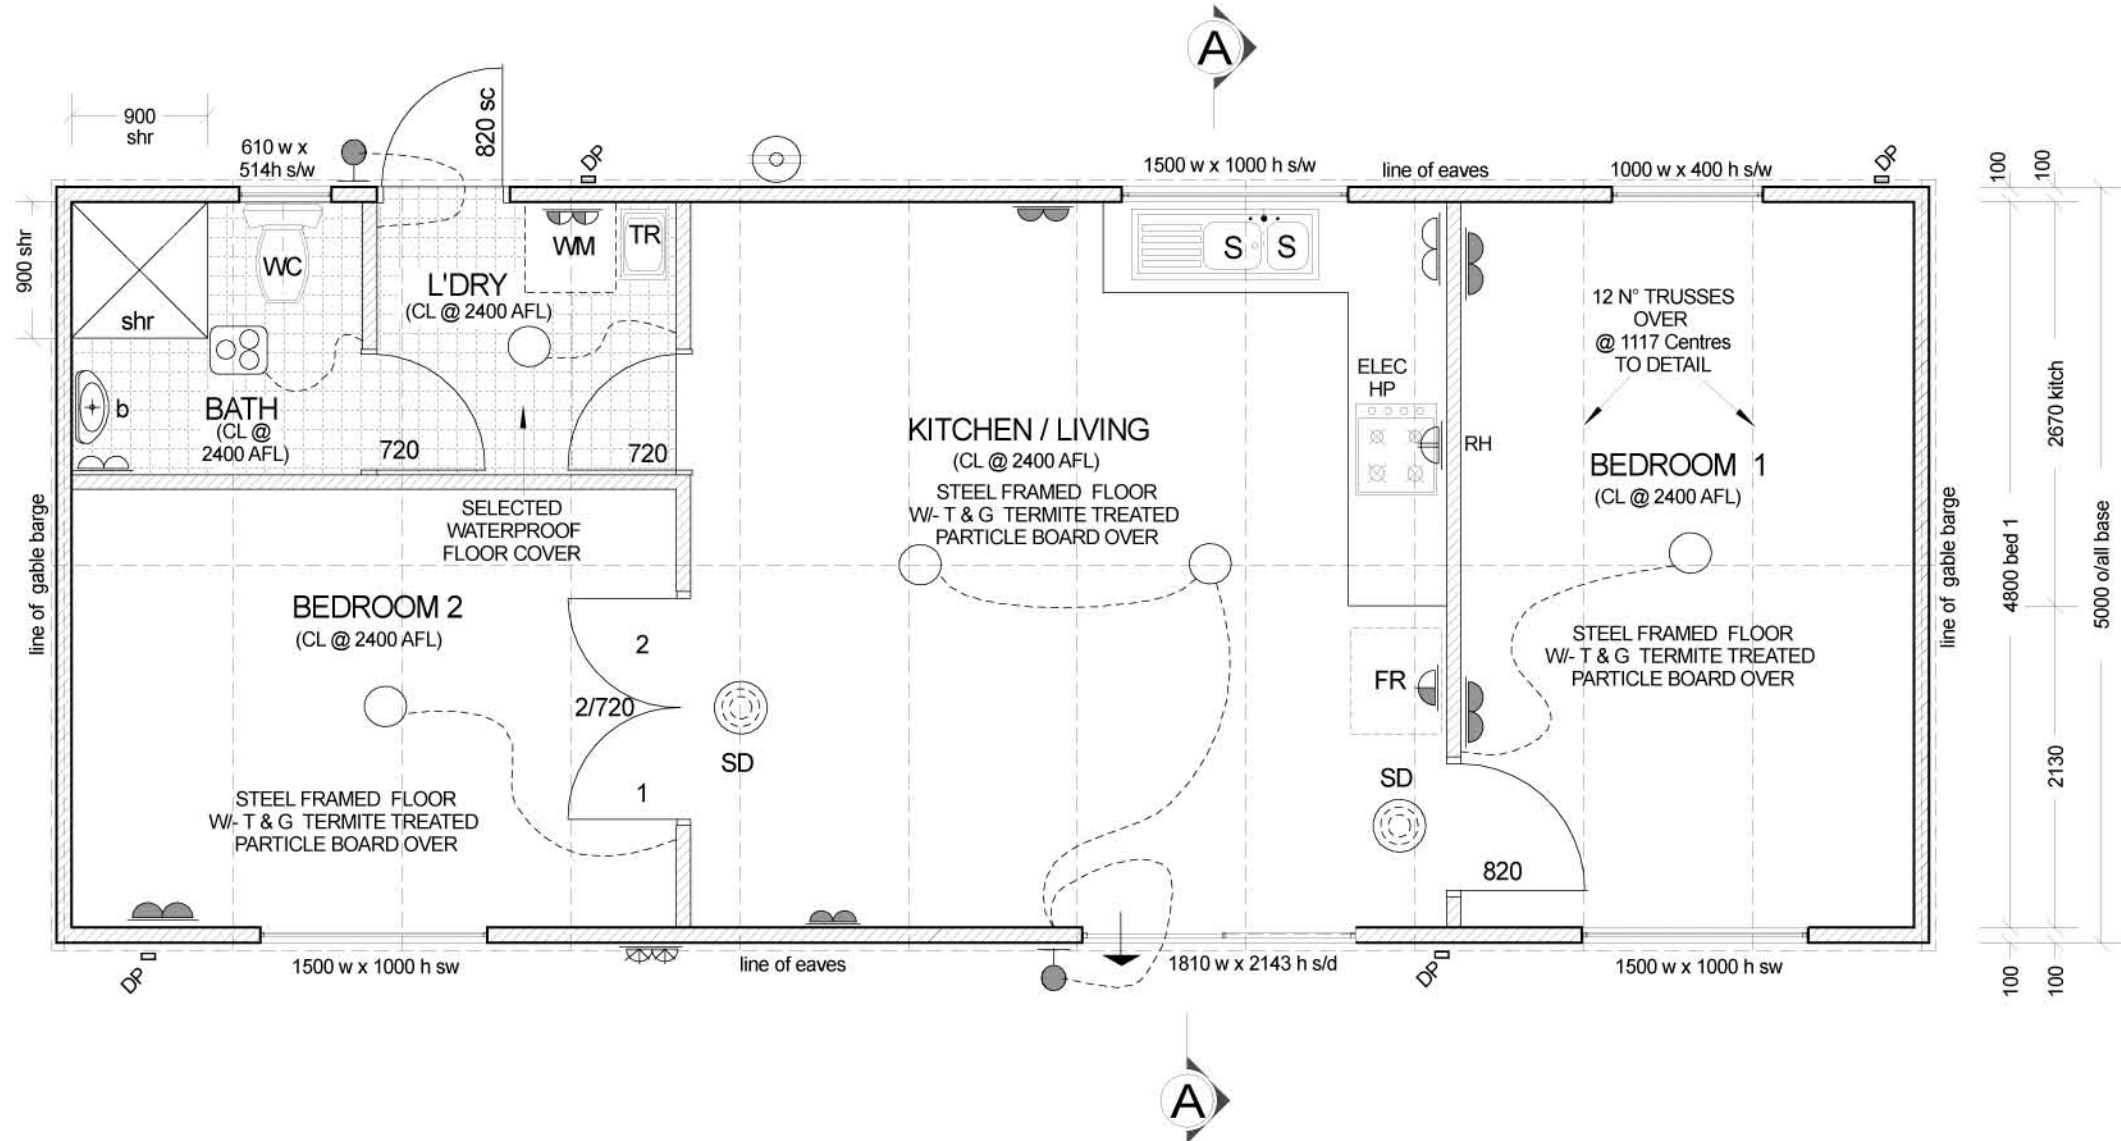


ELECTRICAL LEGEND

- CEILING LIGHT
- ⊙ WALL LIGHT 2000 AFL
- ⌒ DOUBLE GPO @ 300 AFL
- ⌒ DOUBLE GPO @ 975 AFL
- ⌒ GPO FOR APPLIANCE @ 1800AFL
- ⌒ DOUBLE GPO @ 1350 AFL
- ⌒ SINGLE GPO @ 1500 AFL
- ⌒ W/PROOF DGPO @ 1000 AFL
- ⊗ EXHAUST FAN
- ⊗ SMOKE DETECTOR
- ⊗ 50 litre electric storage hwu
- ⊗ IXL TASTIC (fan light heater)

4 2

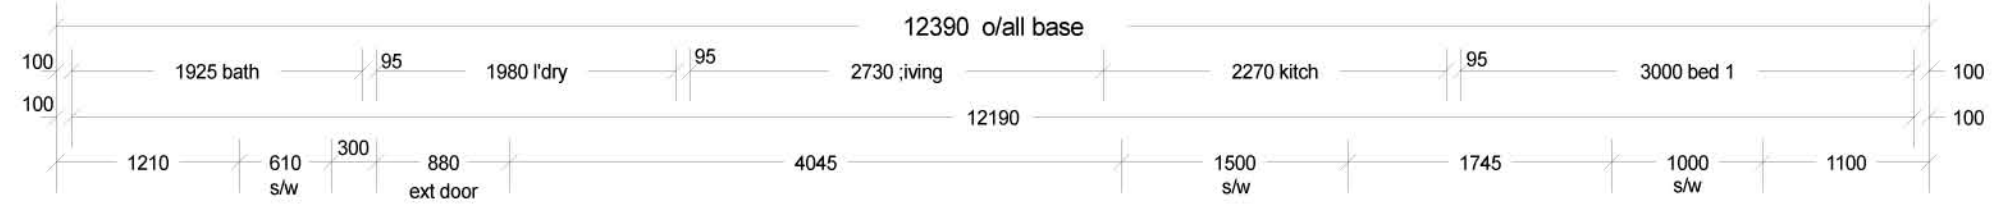

1 3

NOTE : Internal studs are 75mm 1.12mm high tensile steel.
External studs are 90mm 1.12mm high tensile steel.

FLOOR PLAN
scale 1:50

Date Feb 2017
Drawn M.A.
Scale AS SHOWN

COPYRIGHT © RESERVED

Sheet N°
2A OF 4
ISSUE