
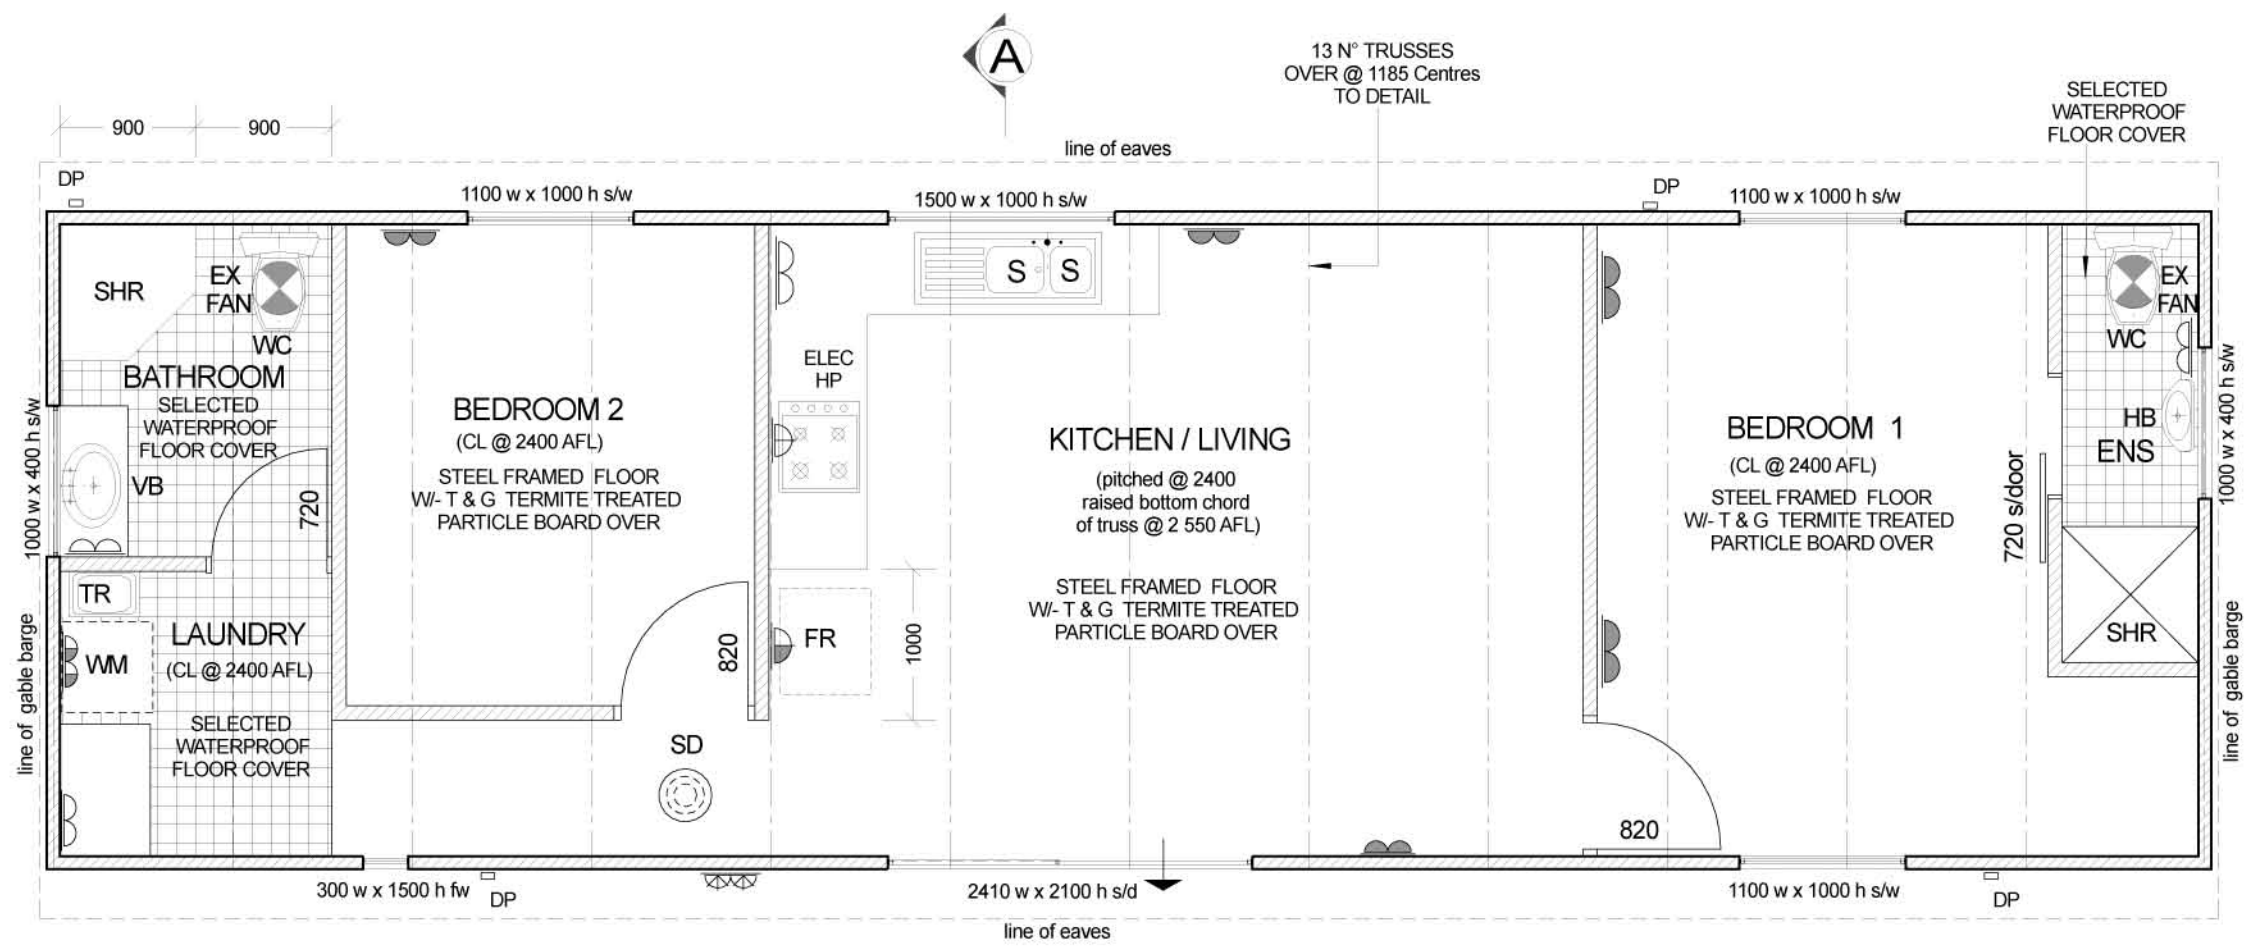


ELECTRICAL LEGEND


- DOUBLE GPO @ 300 AFL
- DOUBLE GPO @ 975 AFL
- GPO FOR APPLIANCE @ 300AFL
- DOUBLE GPO @ 1350 AFL
- SINGLE GPO @ 1500 AFL
- W/PROOF DGPO
- EXHAUST FAN
- SMOKE DETECTOR

3 1

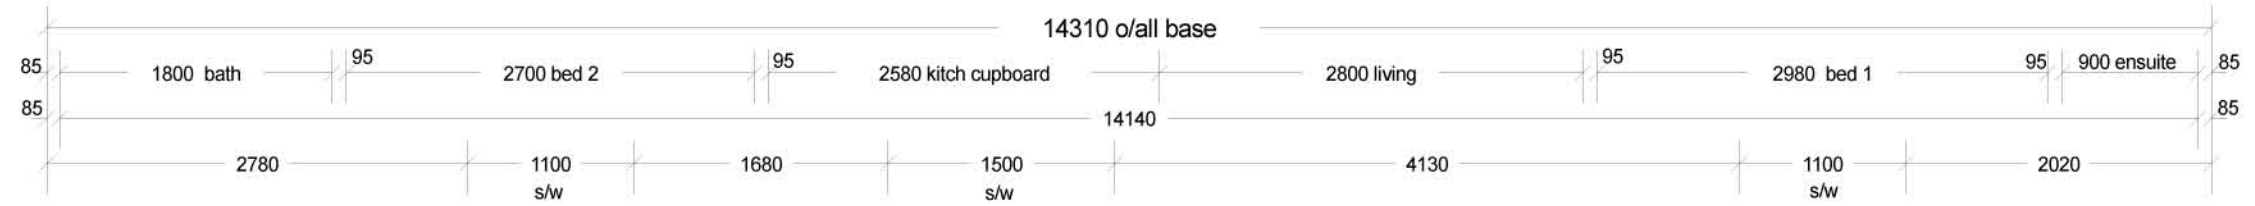

FLOOR PLAN
scale 1:50

NOTE : All studs are 75mm 1.12mm high tensile steel.

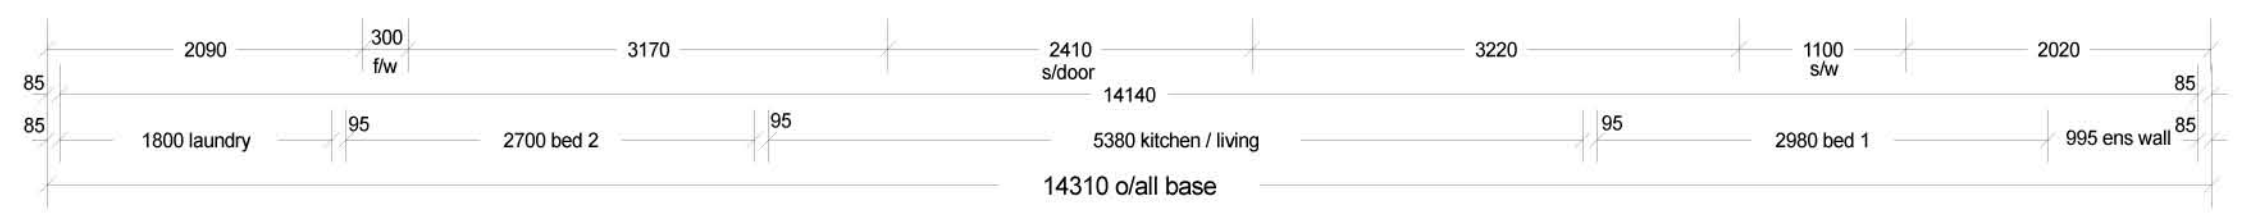

4 2