

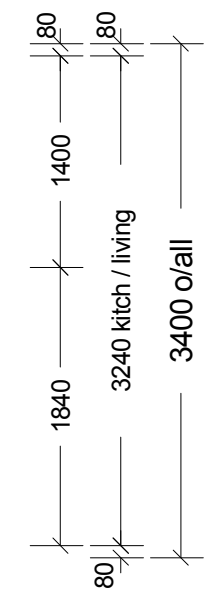
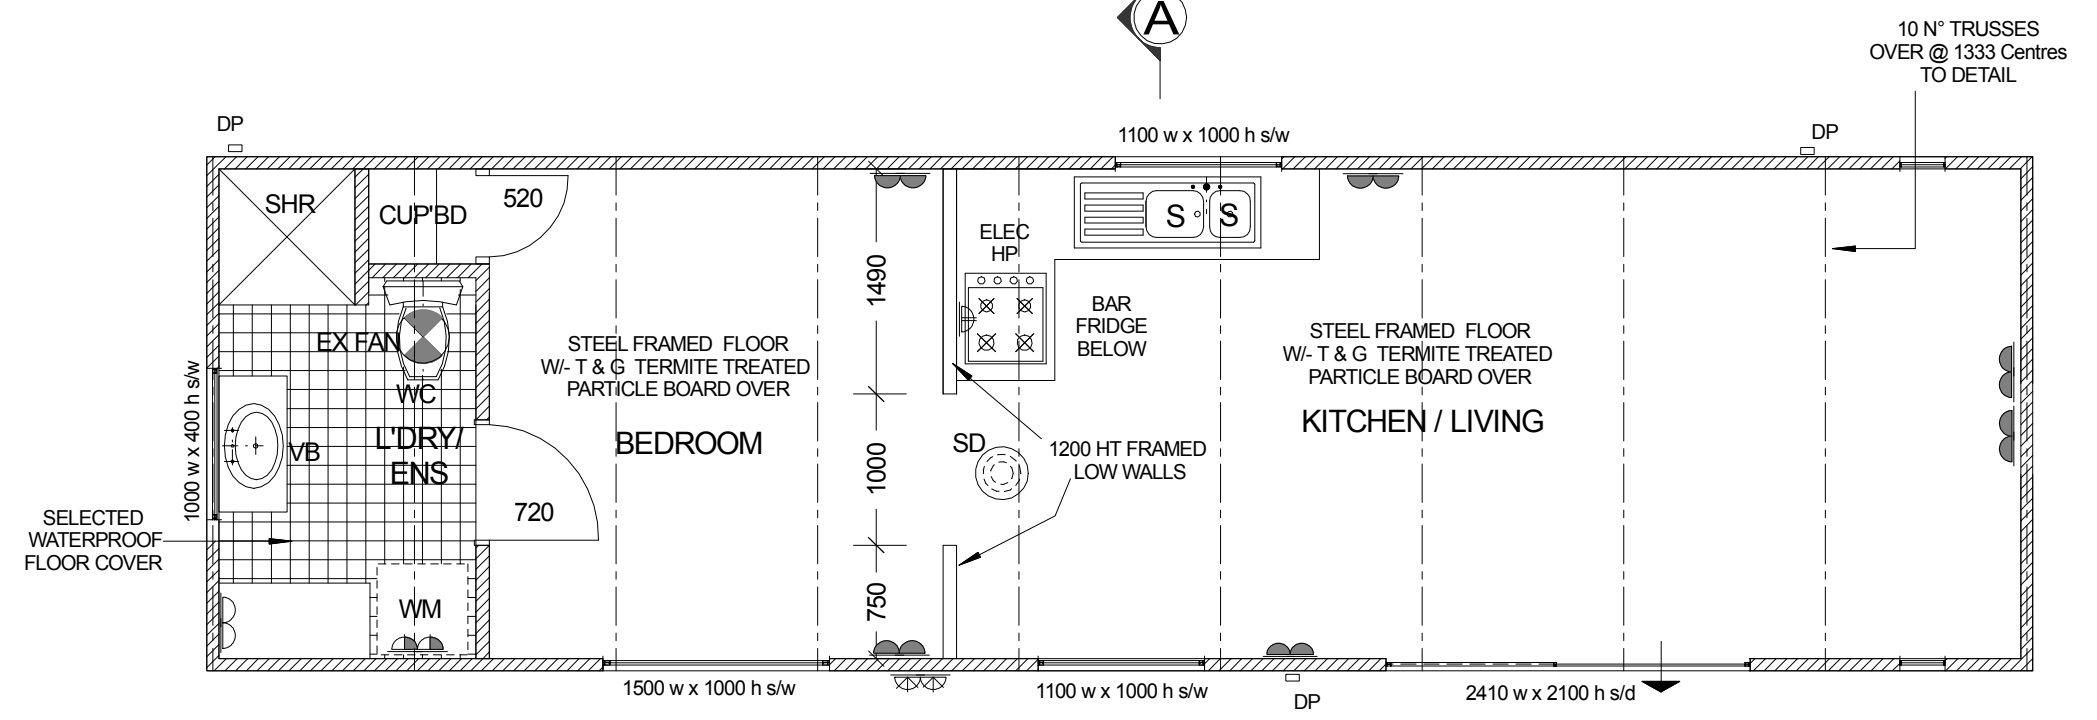


# ELECTRICAL LEGEND

-  DOUBLE GPO @ 300 AFL
-  DOUBLE GPO @ 975 AFL
-  GPO FOR APPLIANCE @ 300AFL
-  DOUBLE GPO @ 1350 AFL
-  W/PROOF DGPO
-  EXHAUST FAN
-  SMOKE DETECTOR

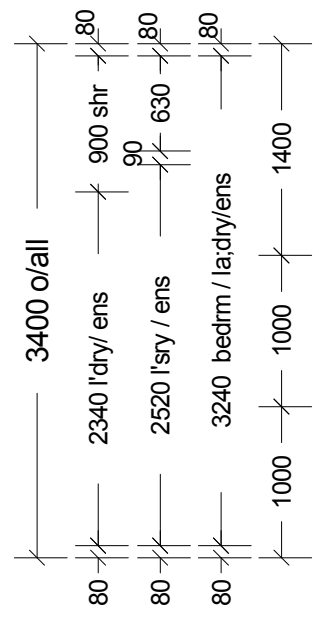

**FLOOR PLAN**  
scale 1:50

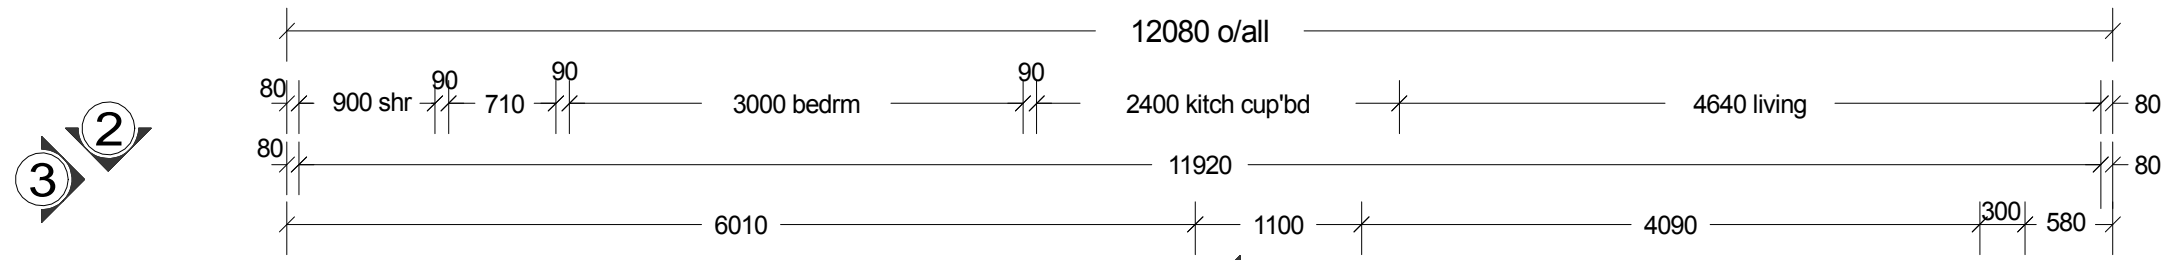