





ELECTRICAL LEGEND

NOTE : Internal studs are 75mm 1.12mm high tensile steel.
External studs are 90mm 1.12mm high tensile steel.

-  DOUBLE GPO @ 300 AFL
-  DOUBLE GPO @ 975 AFL
-  GPO FOR APPLIANCE @ 300AFL
-  DOUBLE GPO @ 1350 AFL
-  SINGLE GPO @ 1500 AFL
-  W/PROOF DGPO
-  EXHAUST FAN
-  SMOKE DETECTOR
-  LIGHT
-  WALL LIGHT

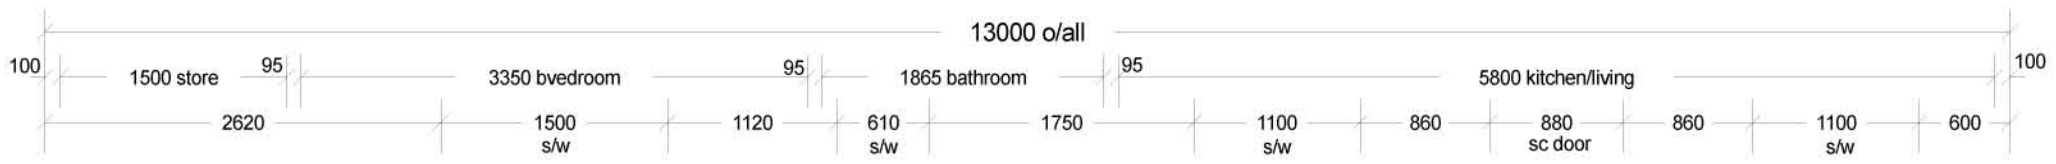

3 1

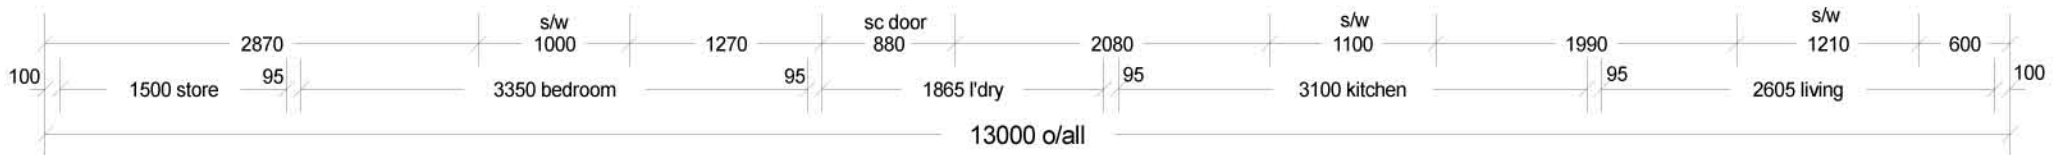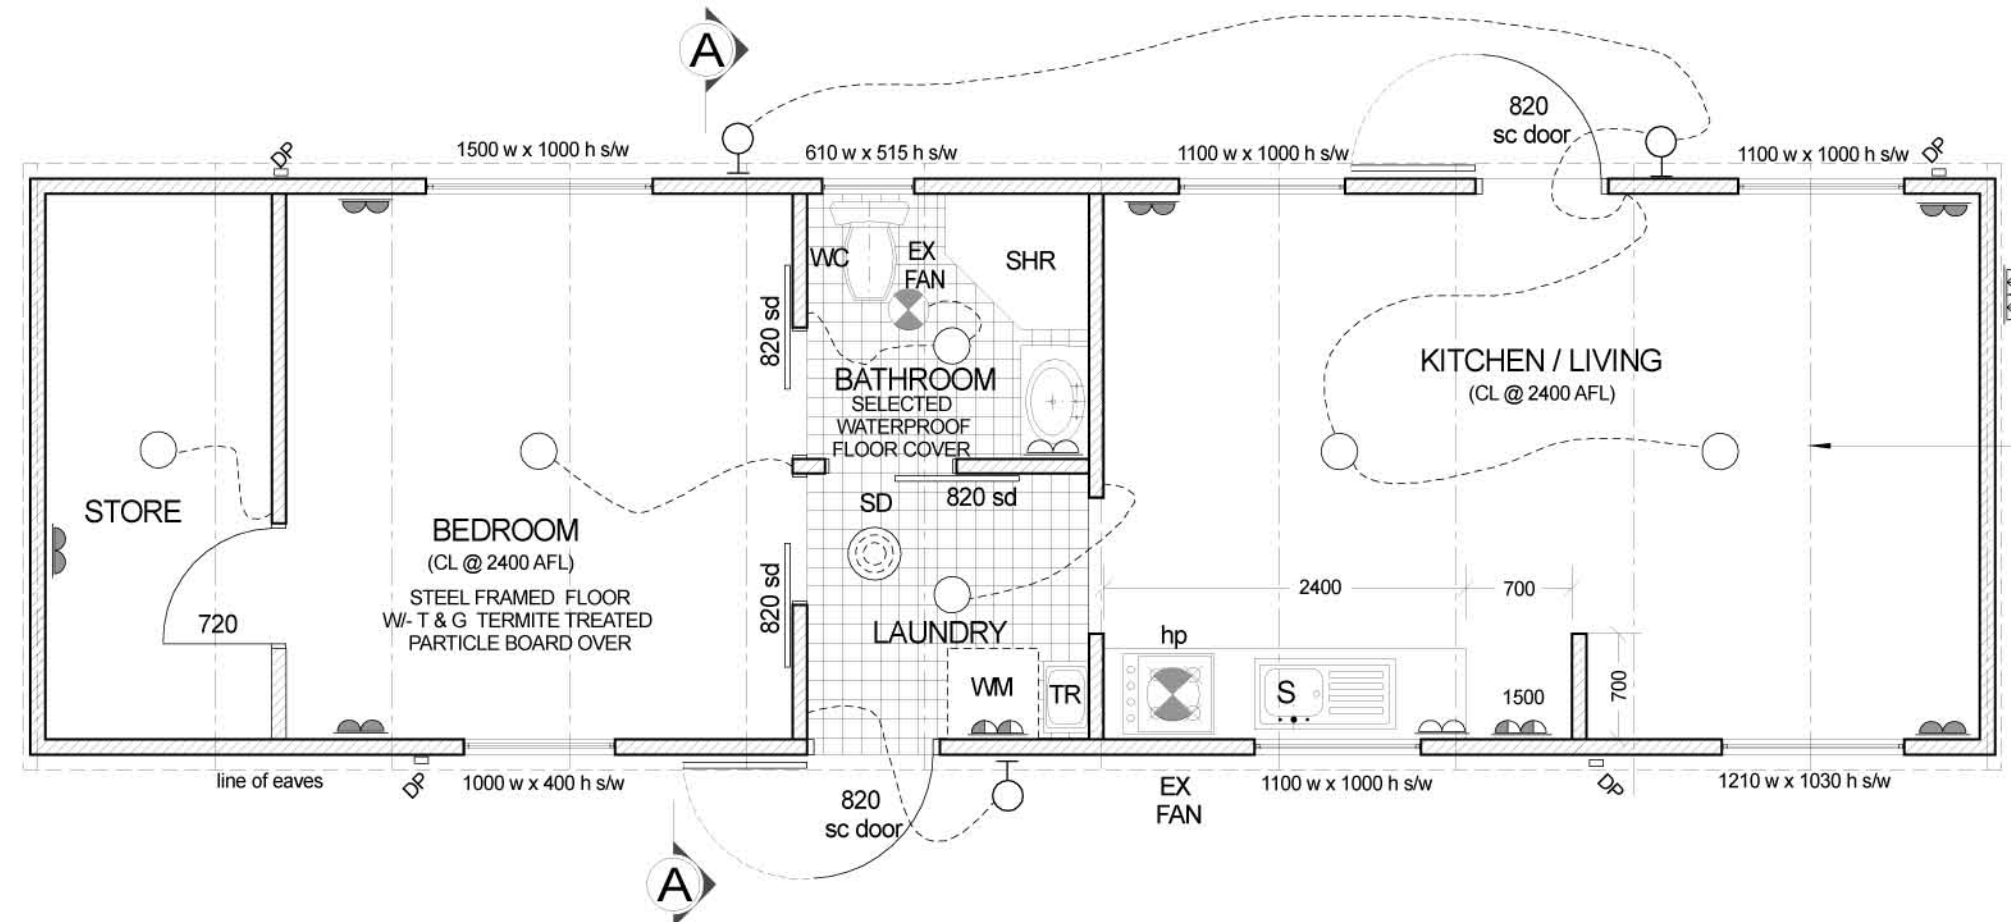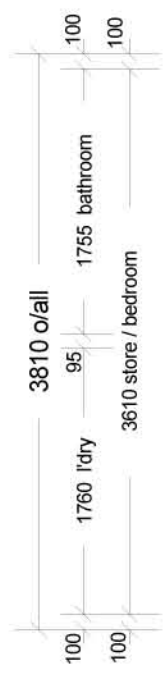

2 4

FLOOR PLAN

scale 1:50