
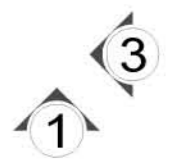
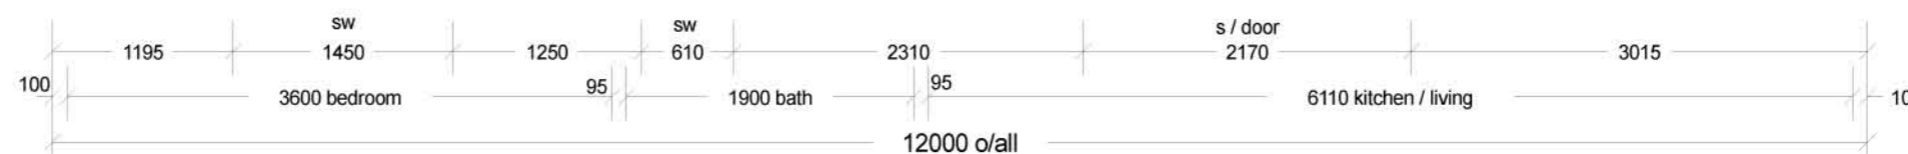
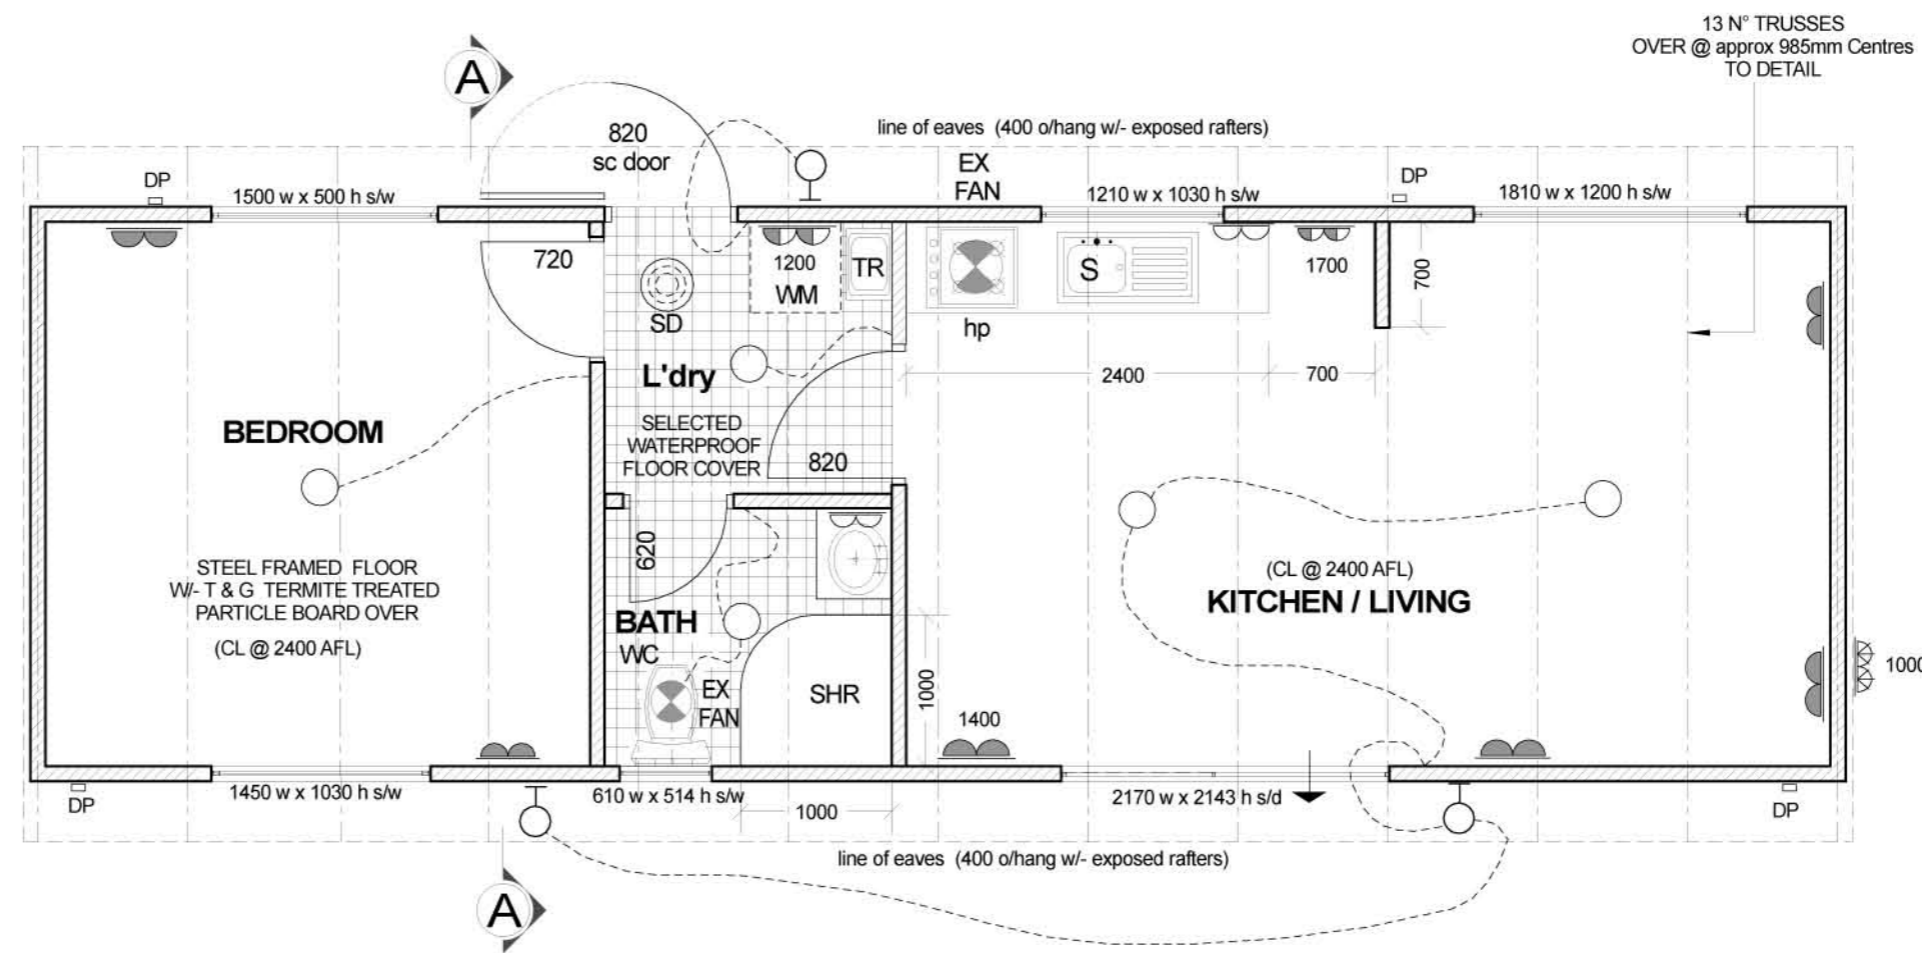
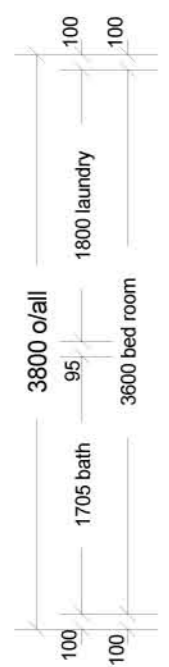


# ELECTRICAL LEGEND

- DOUBLE GPO @ 300 AFL
- DOUBLE GPO @ 975 AFL
- GPO FOR APPLIANCE @ 300AFL
- DOUBLE GPO @ 1350 AFL
- SINGLE GPO @ 1500 AFL
- W/PROOF DGPO
- EXHAUST FAN
- SMOKE DETECTOR
- LIGHT
- WALL LIGHT

NOTE : Internal studs are 75mm 1.12mm high tensile steel.

External studs are 90mm 1.12mm high tensile steel.

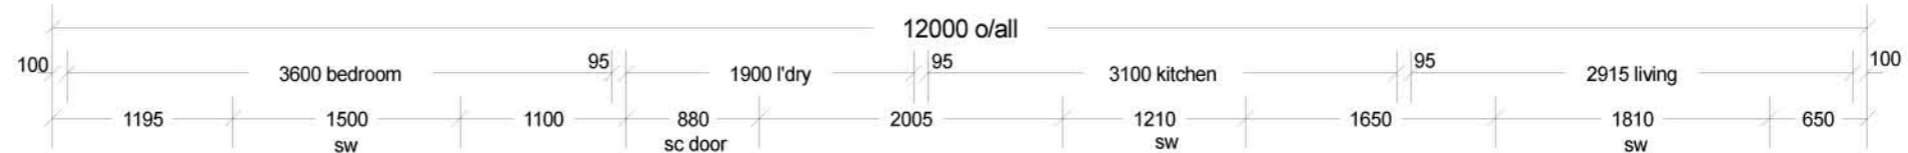

## FLOOR PLAN

scale 1:50