


NOTE : Internal studs are 75mm 1.12mm high tensile steel.  
 External studs are 90mm 1.12mm high tensile steel.

4 2

ELECTRICAL LEGEND			
	CEILING LIGHT		W/PROOF DGPO @ 1000 AFL
	WALL LIGHT 2000 AFL		EXHAUST FAN
	DOUBLE GPO @ 300 AFL		SMOKE DETECTOR
	DOUBLE GPO @ 975 AFL		50 litre electric storage hwu
	GPO FOR APPLIANCE @ 1800 AFL		IXL TASTIC (fan light heater)
	DOUBLE GPO @ 1350 AFL		
	SINGLE GPO @ 1500 AFL		

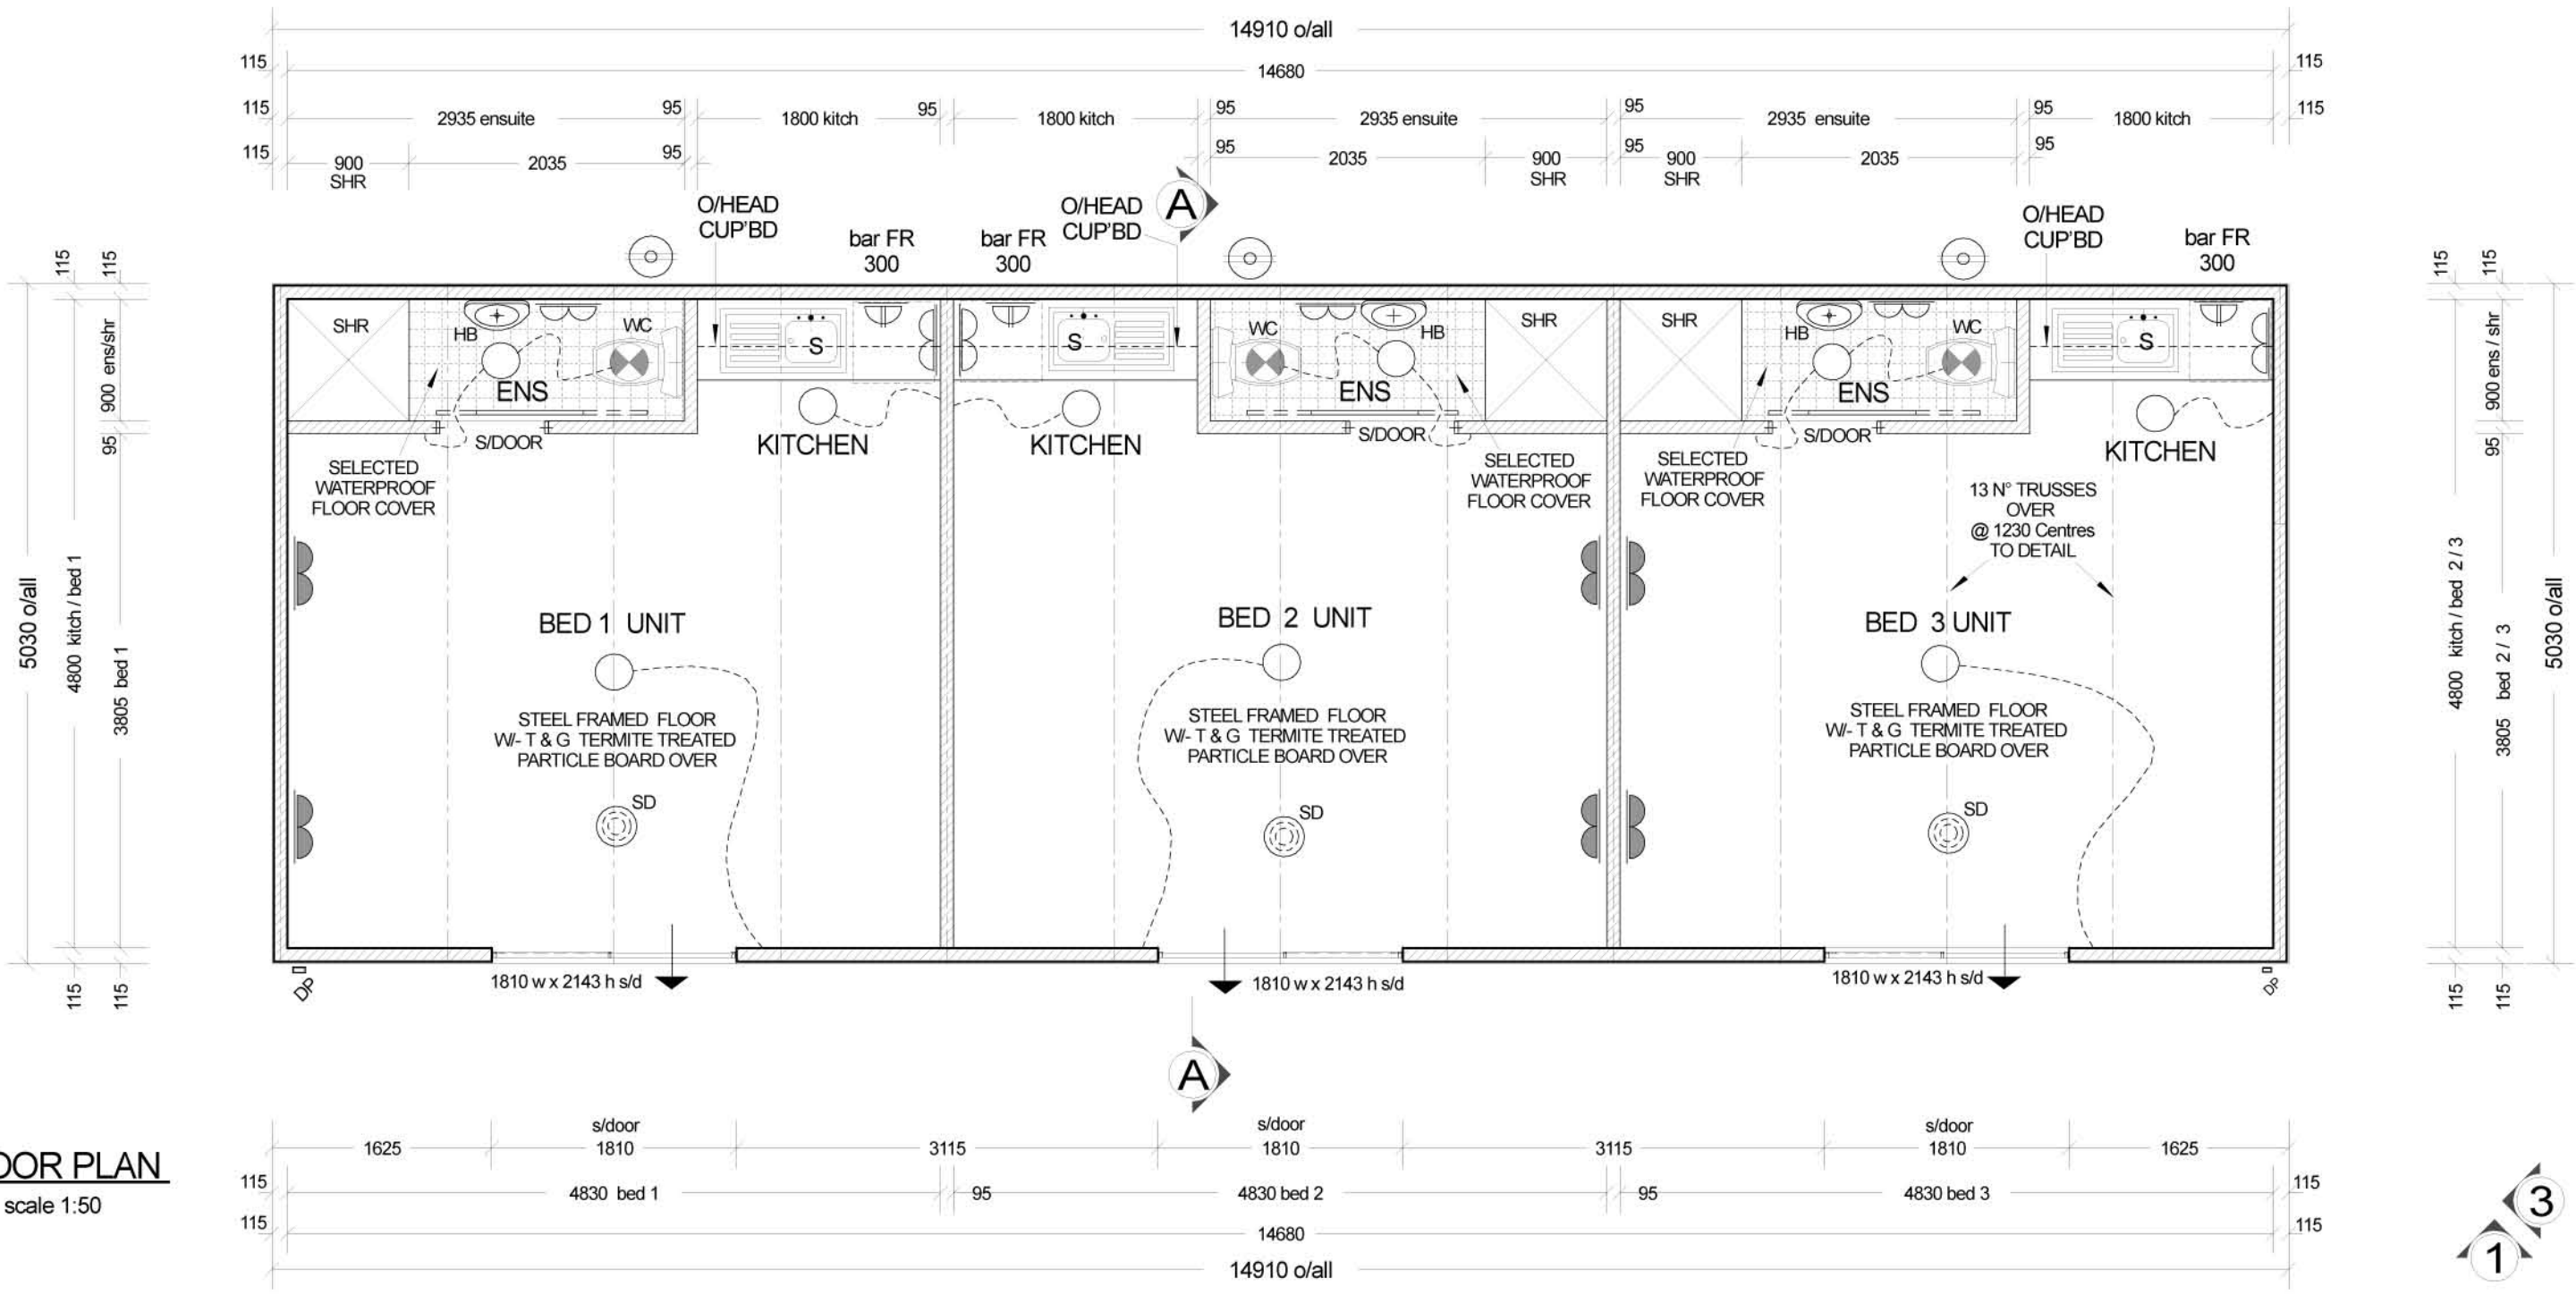

**FLOOR PLAN**  
scale 1:50

3 1

THE APPROVED SIGNATURE ON THIS DRAWING ENDORSES ITS USE FOR CONSTRUCTION APPROVED	<b>Proposed Transportable Residences</b>  client : Francis Jordan	Date Aug 2018	Sheet N° <b>1A OF 2</b>  ISSUE
		Drawn M.A	
		Scale AS SHOWN	
		email : ras-99@hotmail.com mob : 04020896 94	COPYRIGHT © RESERVED